



PROCUREMENT DEPARTMENT

Teria G. Sheffield
Procurement Director

ADDENDUM # 1

Date: 06/15/2026

PROPOSAL ID #3046


IFB #3046
Planning Building Lobby Renovation

THE FOLLOWING INFORMATION SHALL BE INCORPORATED AS PART OF THE ABOVE MENTIONED SOLICITATION; ALL OTHER TERMS AND CONDITIONS SHALL REMAIN THE SAME.


Change 1: Revise drawing set to include Millwork Details A11.02

Add: Attached Millwork Details A11.02


Copyright : These Drawings are the property of DP3 Architects, Ltd., and reuse on any other project without written permission will result in legal action.

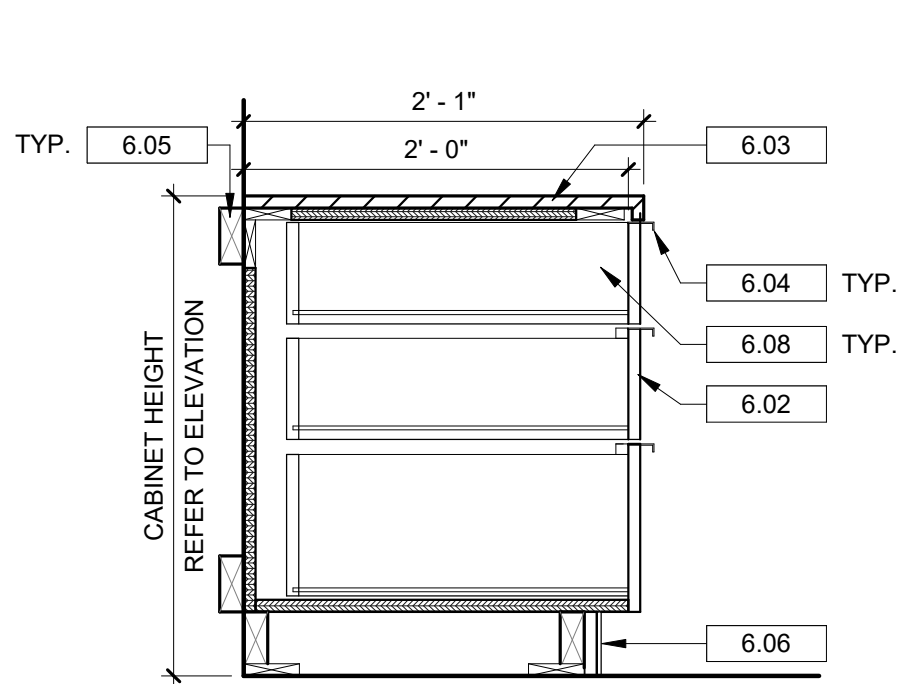


1 SECTION AT 3 DRAWER BASE AT WALL
A11.02 1" = 1'-0"

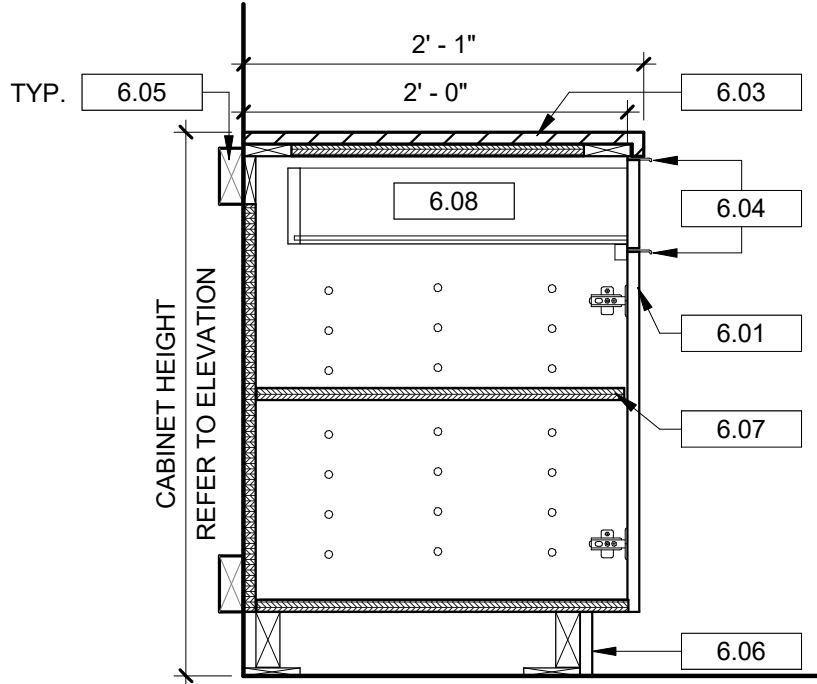


2 SECTION AT BASE CABINET AT WALL
A11.02 1" = 1'-0"

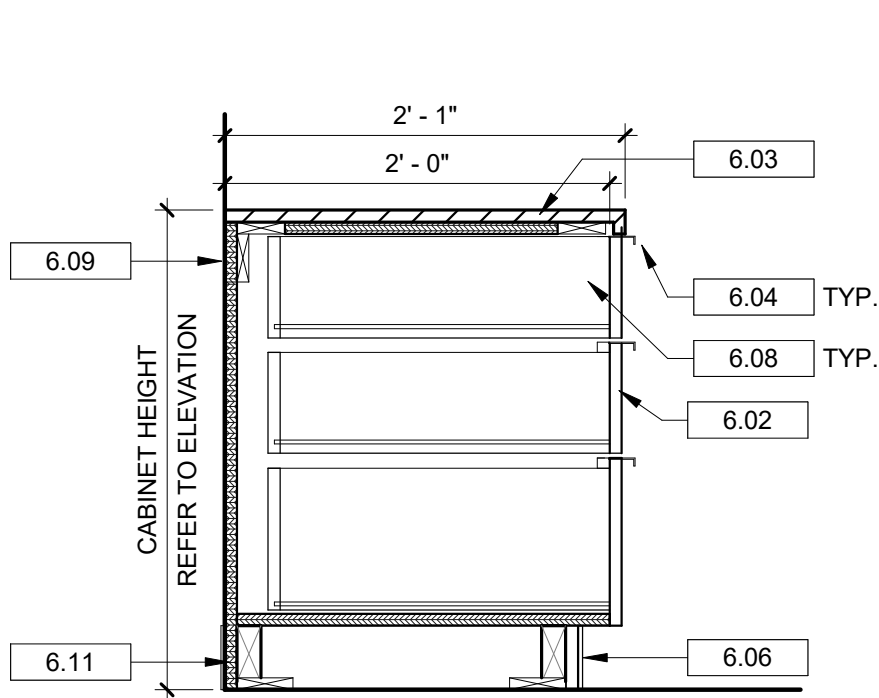


3 SECTION AT TYPICAL 3 DRAWER BASE
A11.02 1" = 1'-0"

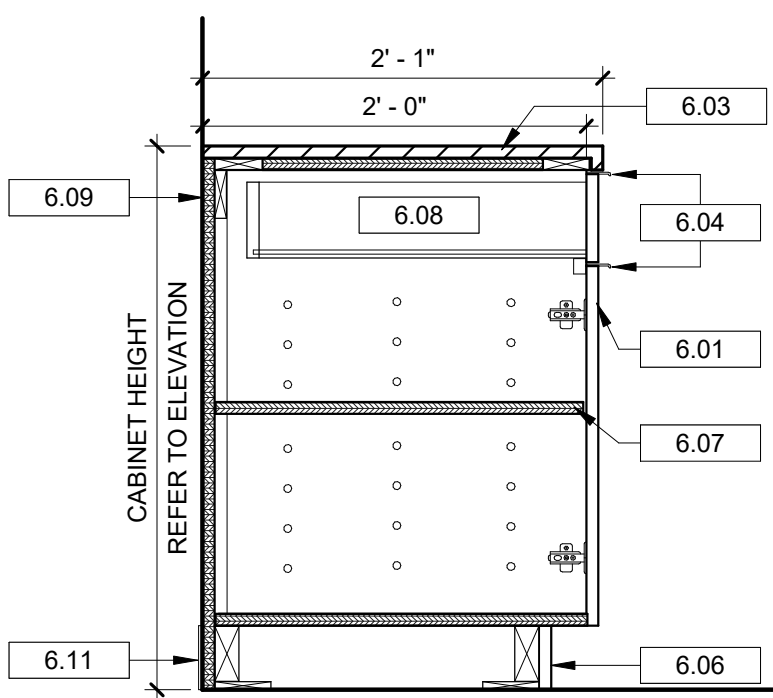

4 SECTION AT TYPICAL BASE CABINET
A11.02 1" = 1'-0"

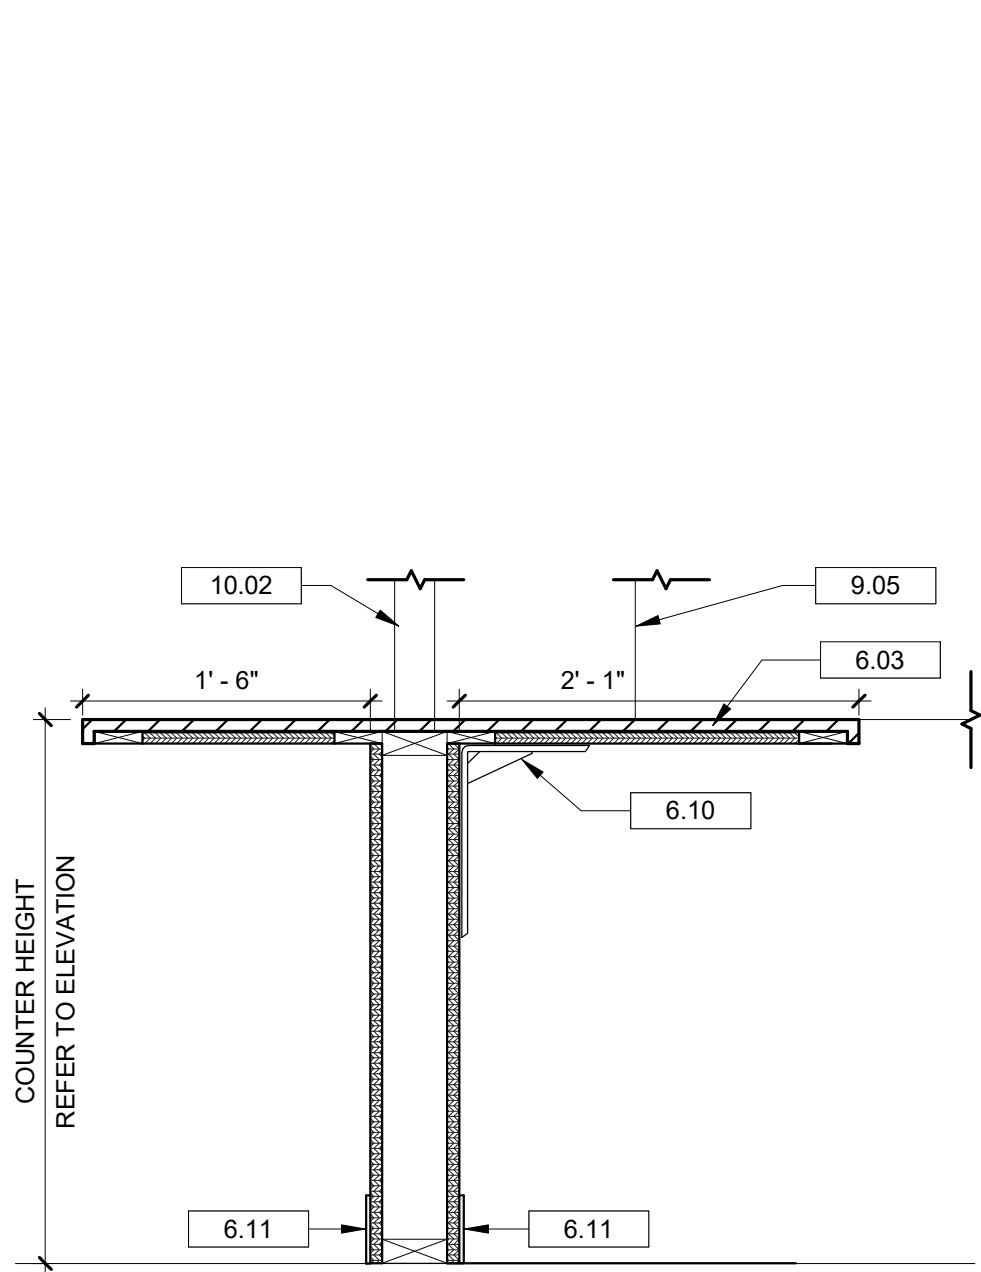

5 SECTION AT LOBBY COUNTER
A11.02 1" = 1'-0"

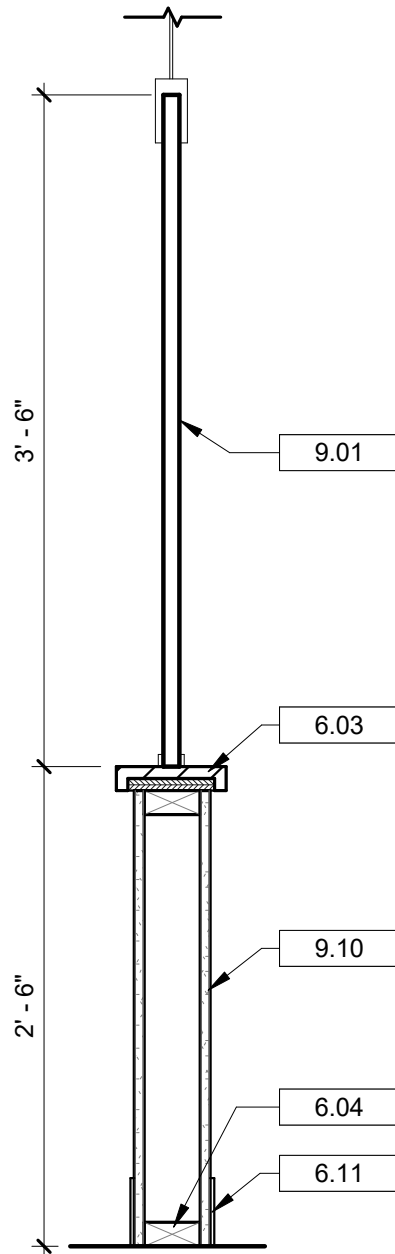

6 SECTION AT TYPICAL KNEE WALL COUNTER
A11.02 1" = 1'-0"

GENERAL CASEWORK NOTES

- THE CONTRACTOR SHALL VERIFY AND COORDINATE CLEAR DIMENSIONS REQUIRED FOR EQUIPMENT WHICH IS LOCATED WITHIN OR ADJACENT TO ANY PIECE OF CASEWORK (REFER TO FLOOR PLANS FOR EQUIPMENT LOCATIONS).
- CASEWORK DIMENSIONS SHALL BE FIELD VERIFIED PRIOR TO UNIT FABRICATION AND INSTALLATION.
- COUNTERTOPS, UNLESS OTHERWISE NOTED, SHALL HAVE A 4" HIGH BACKSPLASH AND SIDE SPLASH SCRIBED TO CONFORM TO THE SURFACE OF ABUTTING WALLS AT BACKS AND ENDS. COUNTERTOPS AND BACKSPLASHES SHALL BE CAULKED TO THE WALL.
- CASEWORK FABRICATOR AND INSTALLER SHALL COORDINATE WITH APPROPRIATE SUBCONTRACTORS FOR INSTALLATION OF PLUMBING FIXTURES AND EQUIPMENT WITH ASSOCIATED PIPING AND FITTINGS, AND FOR INSTALLATION OF ELECTRICAL RECEPTACLES, LIGHT FIXTURES, ETC. WITHIN THE CASEWORK.
- PROVIDE WALL MOUNTED ANGLE SUPPORTS (FINISH TO MATCH THE COLOR AND MATERIAL OF ADJACENT CASEWORK) WHERE NECESSARY FOR SUPPORT OF COUNTERTOPS ABOVE KNEE SPACES.
- PROVIDE SCHEDULED BASE ALONG BOTTOM OF EXPOSED FRONTS, BACKS, SIDES, AND ENDS OF ALL AFFIXED CASEWORK, VERTICAL SUPPORTS, KNEE SPACES, ETC. (U.N.O.)
- PROVIDE CONCEALED BLOCKING FOR MOUNTING OF ALL SHELVING, HOOKS, DISPENSERS, ETC.
- ALL OPENINGS IN COUNTERS SHALL BE CUT IN, NOT SEAMED.

Seal

FURNISHING SYMBOL LEGEND

? NOTE TAG

11 EQUIPMENT/ ACCESSORY

? FINISH TAG

M1 FURNITURE/ MILLWORK TAG

DRAWING NOTES

- 24 INCH DEEP LOCKABLE PLASTIC LAMINATE BASE CABINET WITH DRAWER AND ADJUSTABLE SHELVES.
- 24 INCH DEEP LOCKABLE PLASTIC LAMINATE 3 DRAWER BASE CABINET.
- SOLID SURFACE COUNTERTOP. SCRIBE AND SEAL TO WALL.
- CABINET PULL. TYPICAL.
- 2X WOOD BLOCKING AS REQUIRED.
- TOEKICK WITH BASE AS SCHEDULED.
- ADJUSTABLE SHELVES.
- FULL EXTENSION DRAWER.
- PLASTIC LAMINATE END PANEL.
- UNDERCOUNTER BRACKETS.
- WALL BASE AS SCHEDULED. SEE FINISH SCHEDULE AND LEGEND.
- ACOUSTICAL HANGING DIVIDER. INSTALL BASE AND HANGERS PER MANUFACTURER'S INSTRUCTIONS. REFER TO FINISH LEGEND.
- ACOUSTICAL HANGING DIVIDER BEYOND.
- 5/8 INCH GYPSUM WALL BOARD.
- CUSTOM DESKTOP COUNTER SCREEN POSTS BEYOND.

DP3
ARCHITECTS

DP3 Architects, Ltd.
15 South Main Street, Suite 400
Greenville, SC 29601
864.232.8200
www.DP3architects.com

Project



**YORK COUNTY
PLANNING BUILDING
LOBBY RENOVATION**

Project Number 26102
Drawn By MGN
Checked By MTP
Date 8 JUN 2026

Revisions

A 31 MAR 2026 ISSUE FOR PERMIT
B 08 JUN 2026 ISSUE FOR BID

Drawing

MILLWORK DETAILS

A11.02